 



SCALE 1:100




PLAN VIEW

NOTE: CENTER OF AMPHITHEATRE
1' 6" BELOW GRADE

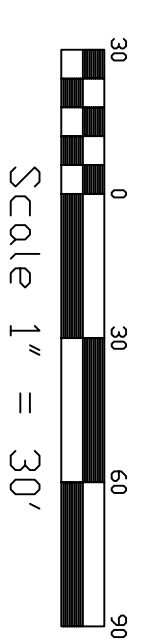


SCALE 1:30


Scale 1" = 30'

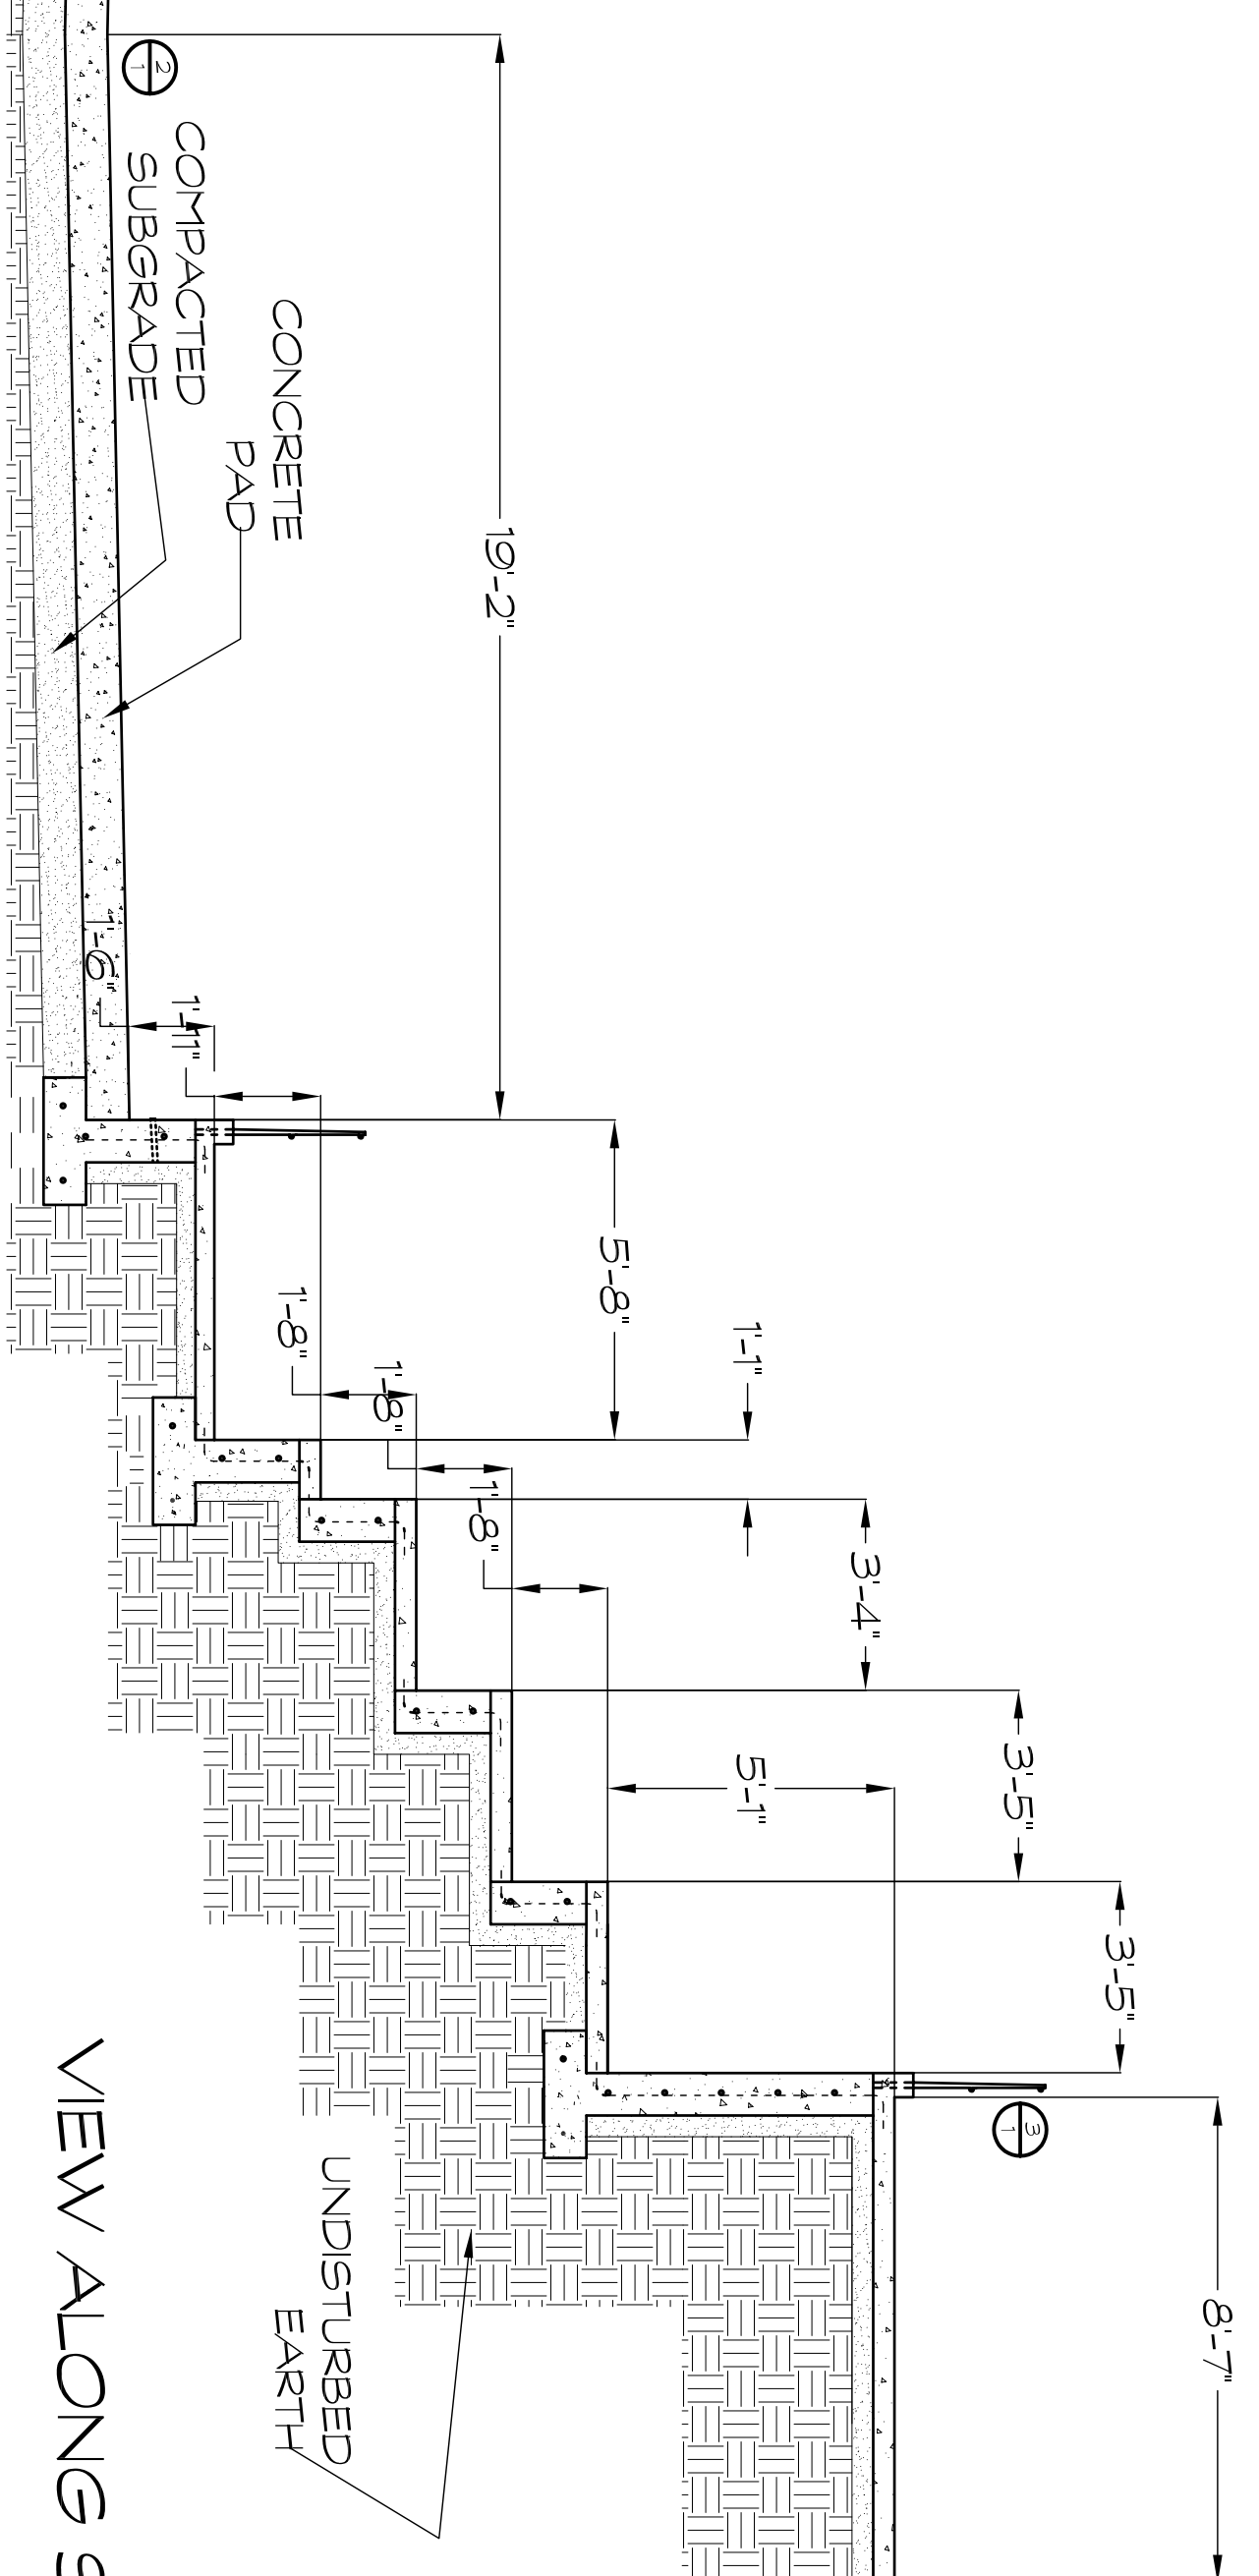

VIEW ALONG SECTION CUT


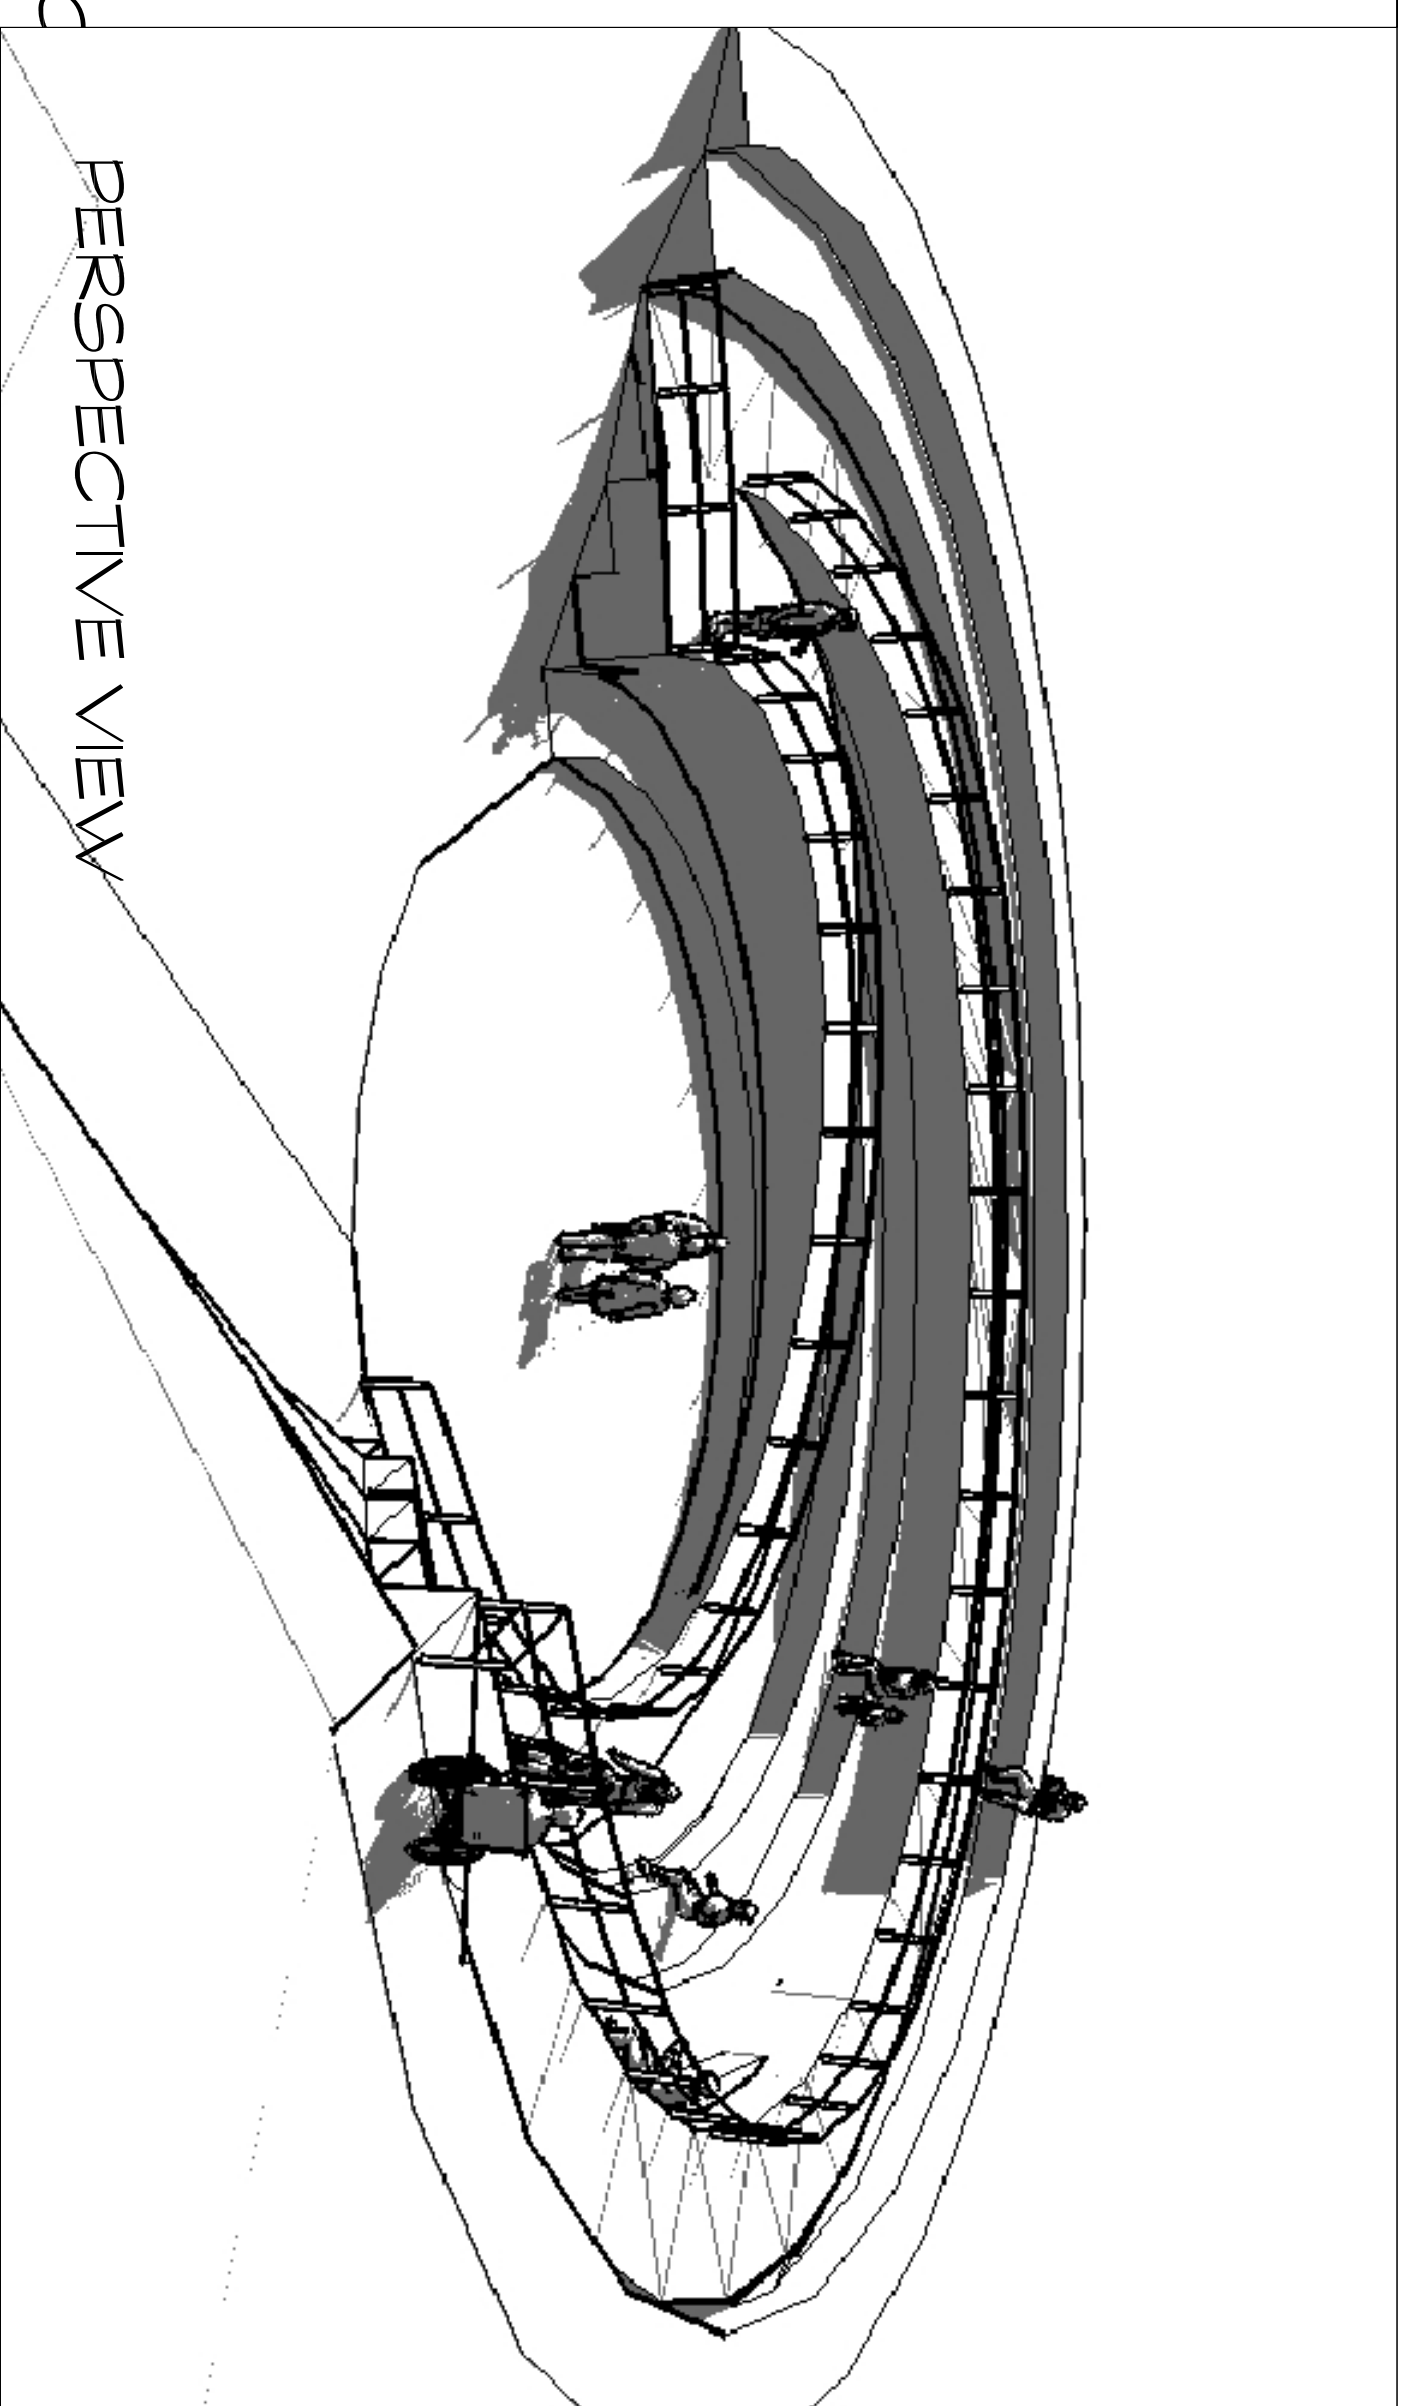


PERSPECTIVE VIEW

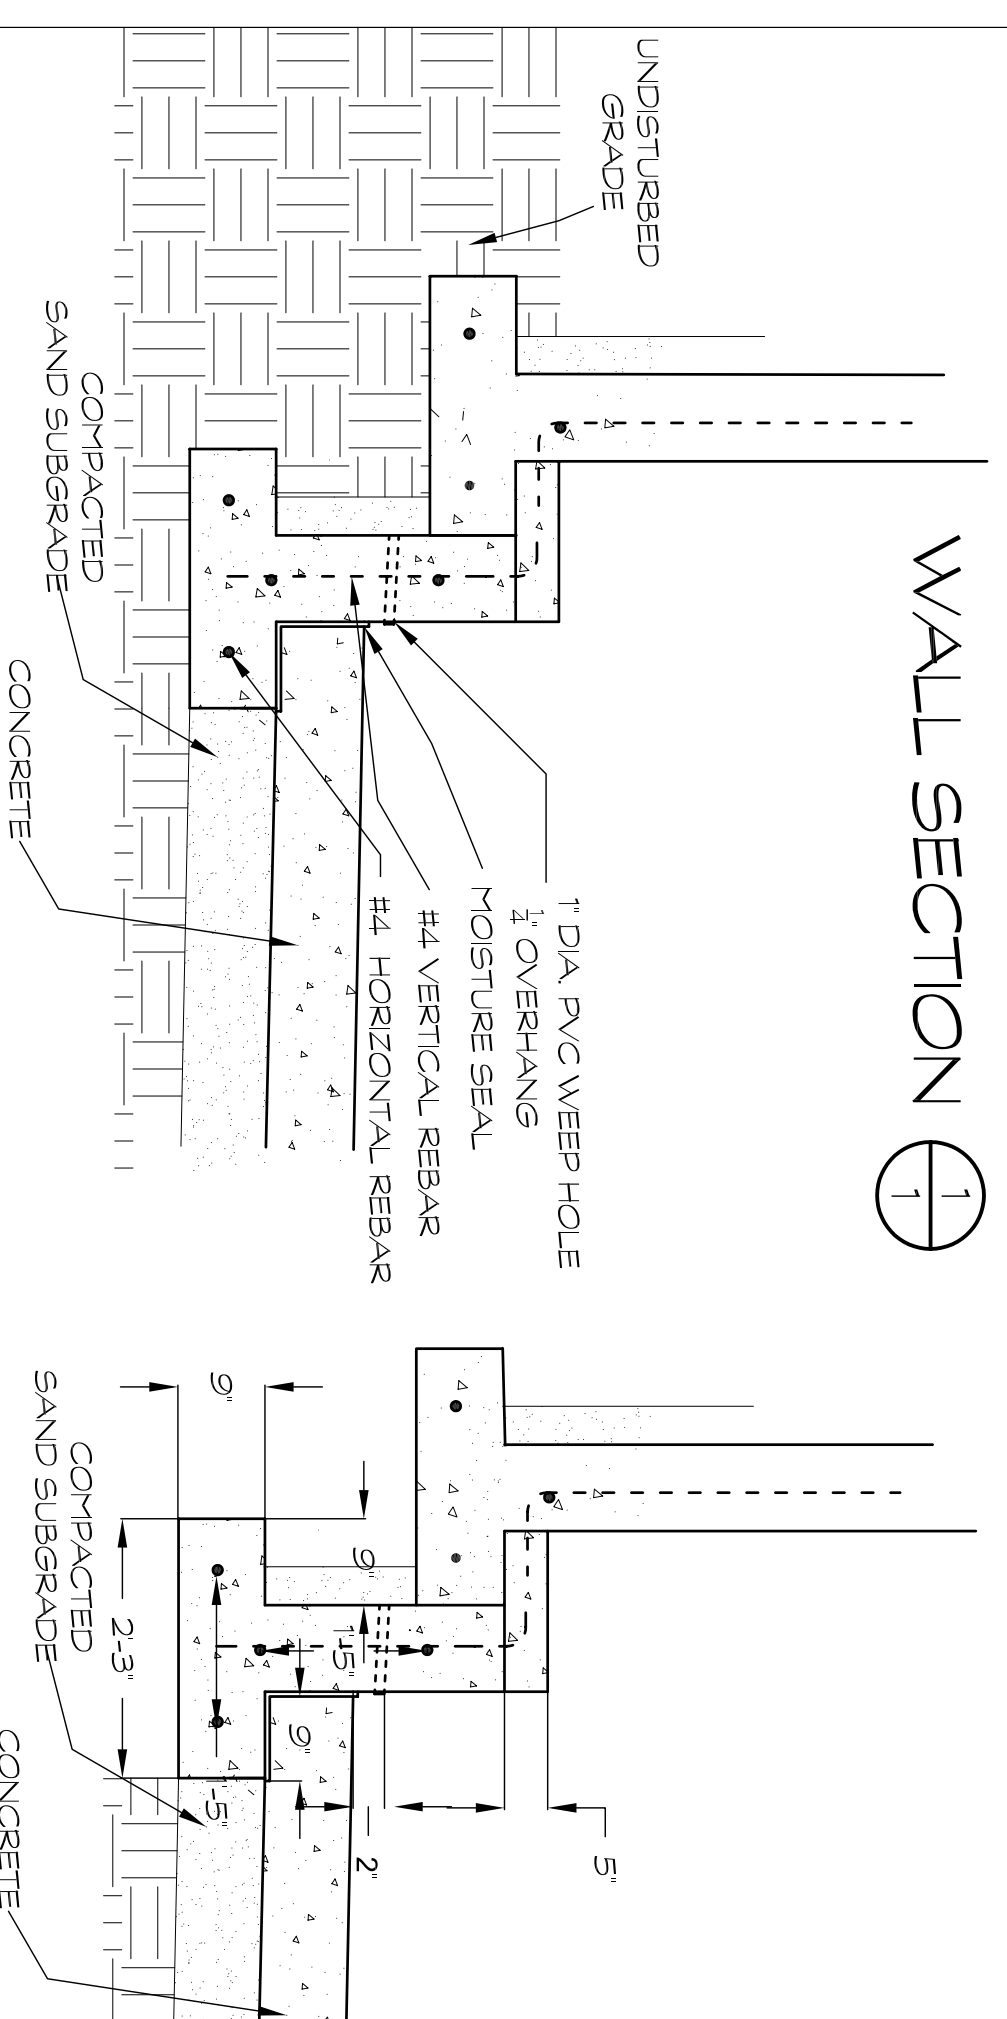



WALL SECTION ①

 SCALE 1:20

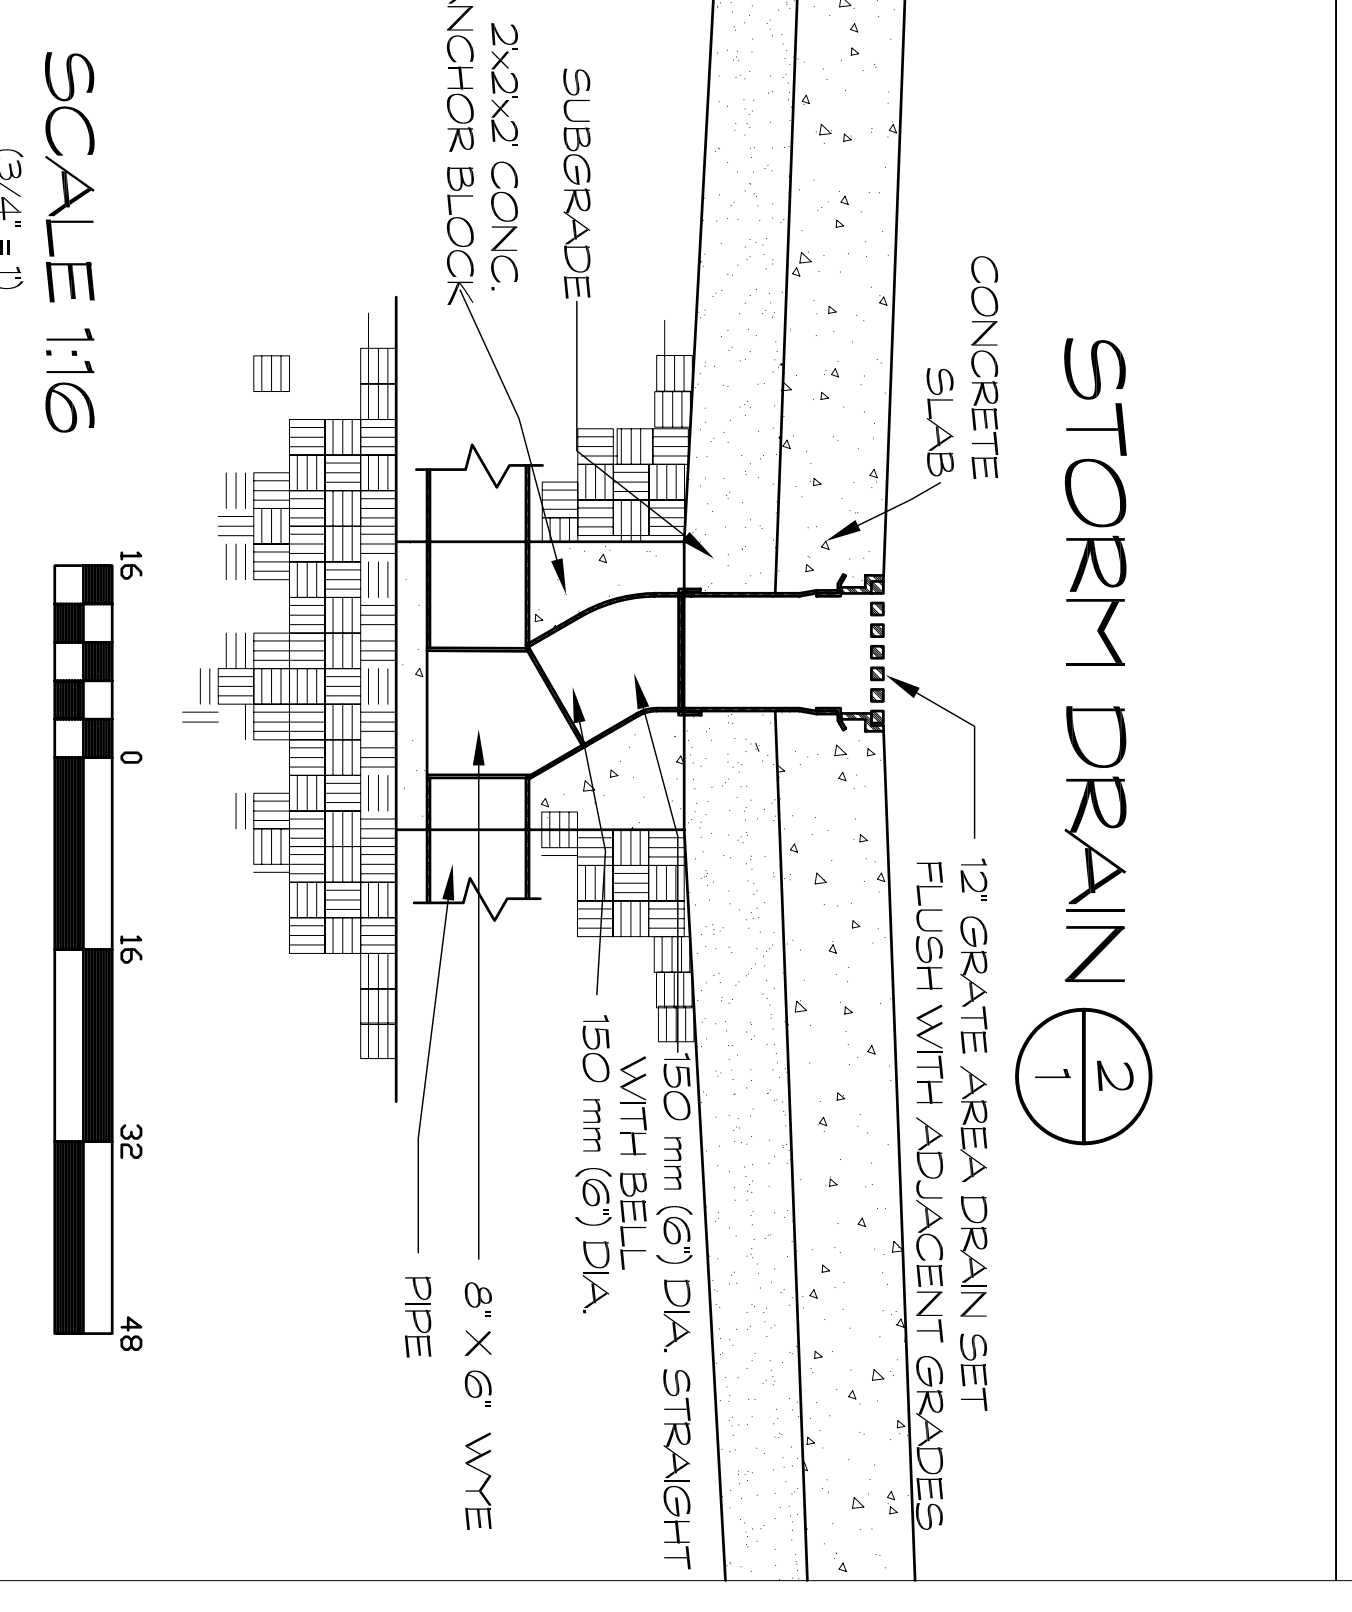

STORM DRAIN ②


SCALE 1:16

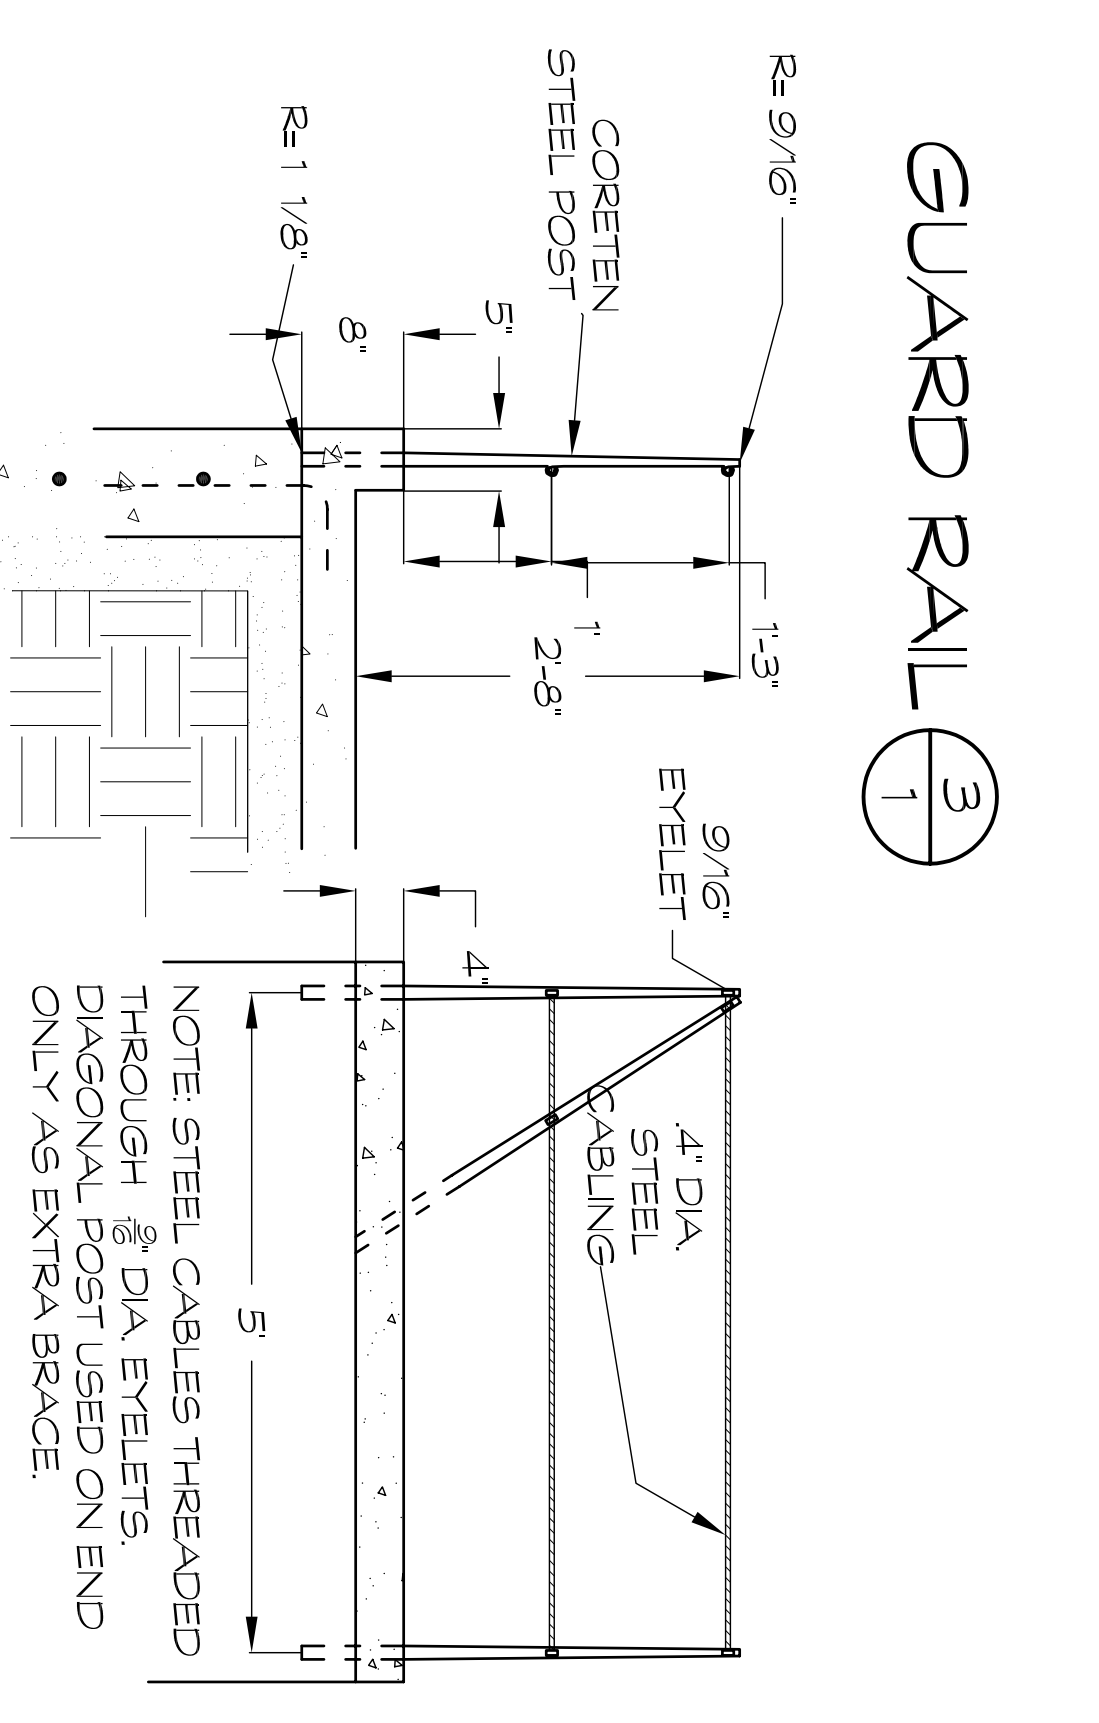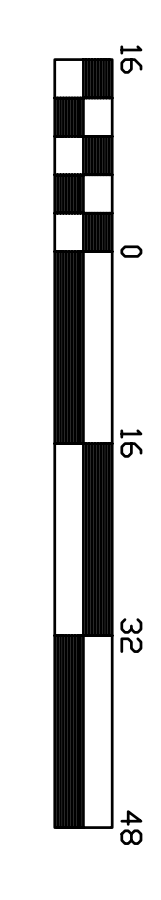

GUARD RAIL ③

SCALE 1:16

(3/4" = 1')

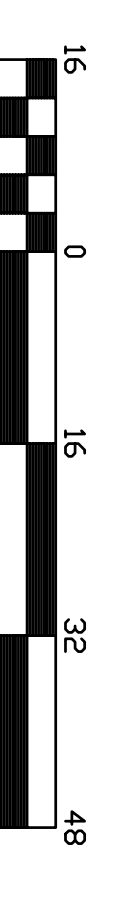

NOTE: STEEL CABLES THREADED THROUGH 3/8" DIA EYELETS. DIAGONAL POST USED ON END ONLY AS EXTRA BRACE.